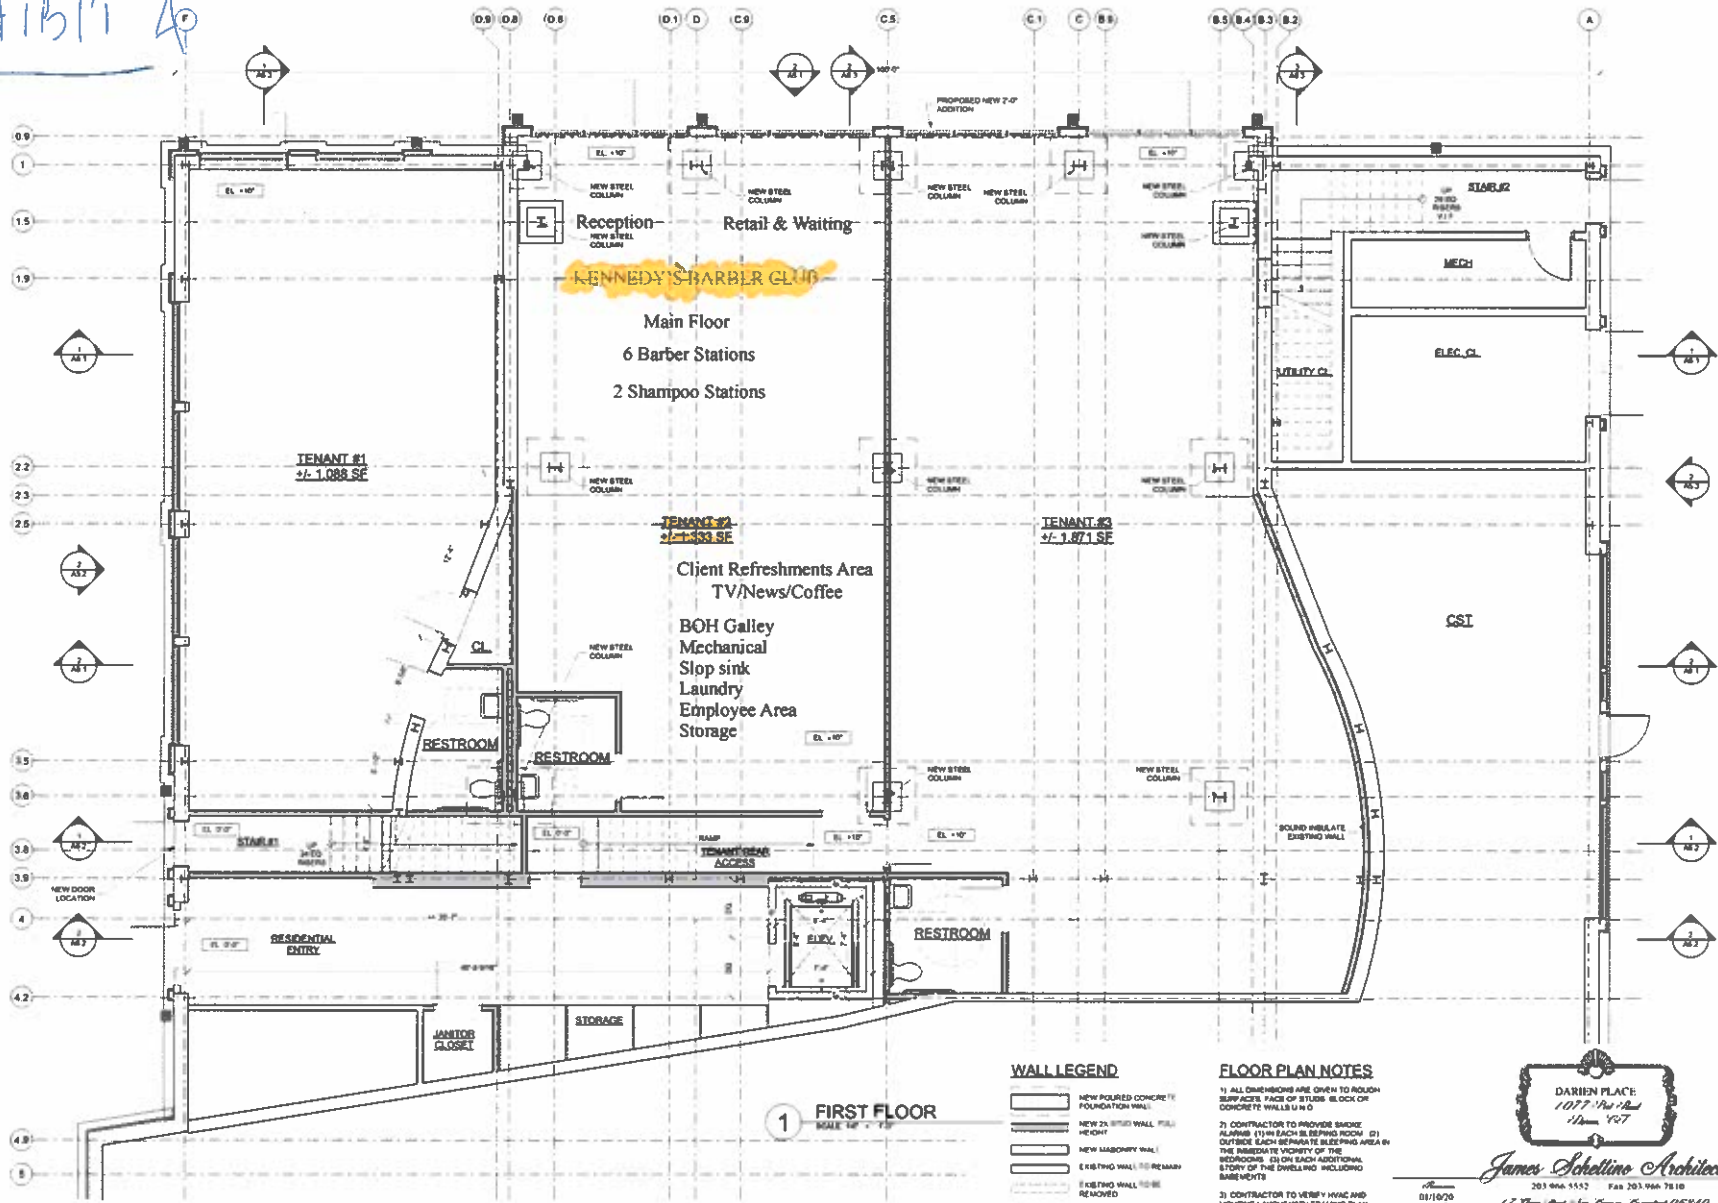


EXHIBIT A



1 FIRST FLOOR
SCALE 1/8" = 1'-0"

WALL LEGEND

- NEW POURED CONCRETE FOUNDATION WALL
- NEW 2x4 STUD WALL FULL HEIGHT
- NEW MASONRY WALL
- EXISTING WALL TO REMAIN
- EXISTING WALL TO BE REMOVED

FLOOR PLAN NOTES

- 1) ALL DIMENSIONS ARE GIVEN TO FINISH SURFACE, FACE OF STUDS, BLOCK OR CONCRETE WALLS UNLESS NOTED OTHERWISE.
- 2) CONTRACTOR TO PROVIDE SMOKE ALARMS (1) IN EACH SLEEPING ROOM (2) OUTSIDE EACH SEPARATE SLEEPING AREA IN THE IMMEDIATE VICINITY OF THE BEDROOMS (3) ON EACH ADDITIONAL STORY OF THE DWELLING INCLUDING BASEMENTS.
- 3) CONTRACTOR TO VERIFY HVAC AND LIGHTING LAYOUT WITH FRAMING PLAN.

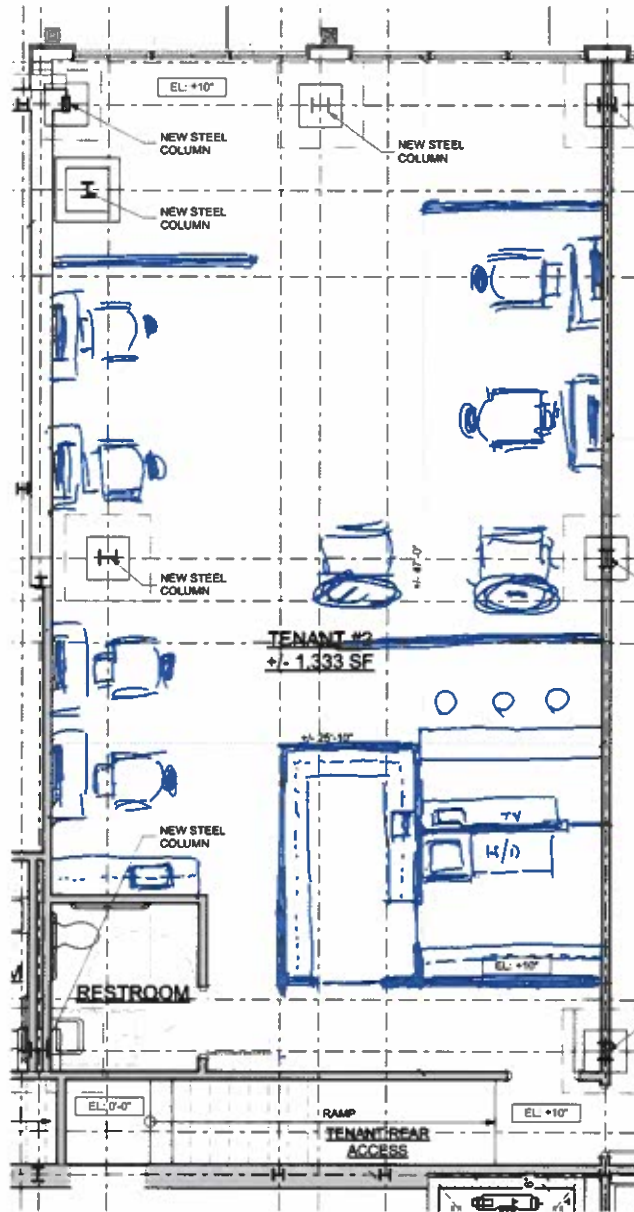


James Scheltino Architects 2024 1915
203 966-5552 Fax 203 966-7810
17 New Street • New Haven, Connecticut 06510
www.james-scheltino.com

DESIGN DEVELOPMENT

EXHIBIT B

 
 
 

DRAFT
FLOOR
PLAN



FLOOR PLAN NOTES

1) ALL DIMENSIONS ARE GIVEN TO ROUGH SURFACES, FACE OF STUDS, BLOCK OR CONCRETE WALLS U.N.O.

WALL LEGEND

-  NEW POURED CONCRETE FOUNDATION WALL
-  NEW 2X METAL STUD WALL, FULL HEIGHT
-  NEW MASONRY WALL
-  EXISTING WALL TO REMAIN

1 FIRST FLOOR
SCALE: 1/4" = 1'-0"